


SMOCK ALLEY THEATRE: BLACK BOX

ADDRESS:	7 Lower Exchange Street, Temple Bar, Dublin 8
WEBSITE:	www.smockalleytheatre.com
DESCRIPTION:	Black box space with good technical resources in a central location within one of the festival's busiest venues
RECOMMENDED FOR:	<ul style="list-style-type: none">o Theatre, comedy. 60 minutes durationo Shared venue - 2 shows per day.
NOT RECOMMENDED FOR:	<ul style="list-style-type: none">o Limited set storage space. Please contact the Production Manager for further details
CAPACITY:	Capacity 70 - 80 in raked seating.
TECHNICAL NOTES:	<ul style="list-style-type: none">o Shared LX rig for the duration of the festival. Dublin Fringe Festival will design a shared lighting plan, in consultation with the companieso See tech spec tab for further detailo Dublin Fringe Festival provide a venue manager to oversee the smooth running of the venue, and crew to assist with hanging and focusing the shared LX rig and set up sound equipment. Each company must provide their own design team and technical crew to run their show and turnarounds
ACCESS:	<ul style="list-style-type: none">o Wheelchair accessible.
FRONT OF HOUSE ARRANGEMENTS:	<ul style="list-style-type: none">o Venue box office, front of house staff and bar facilities

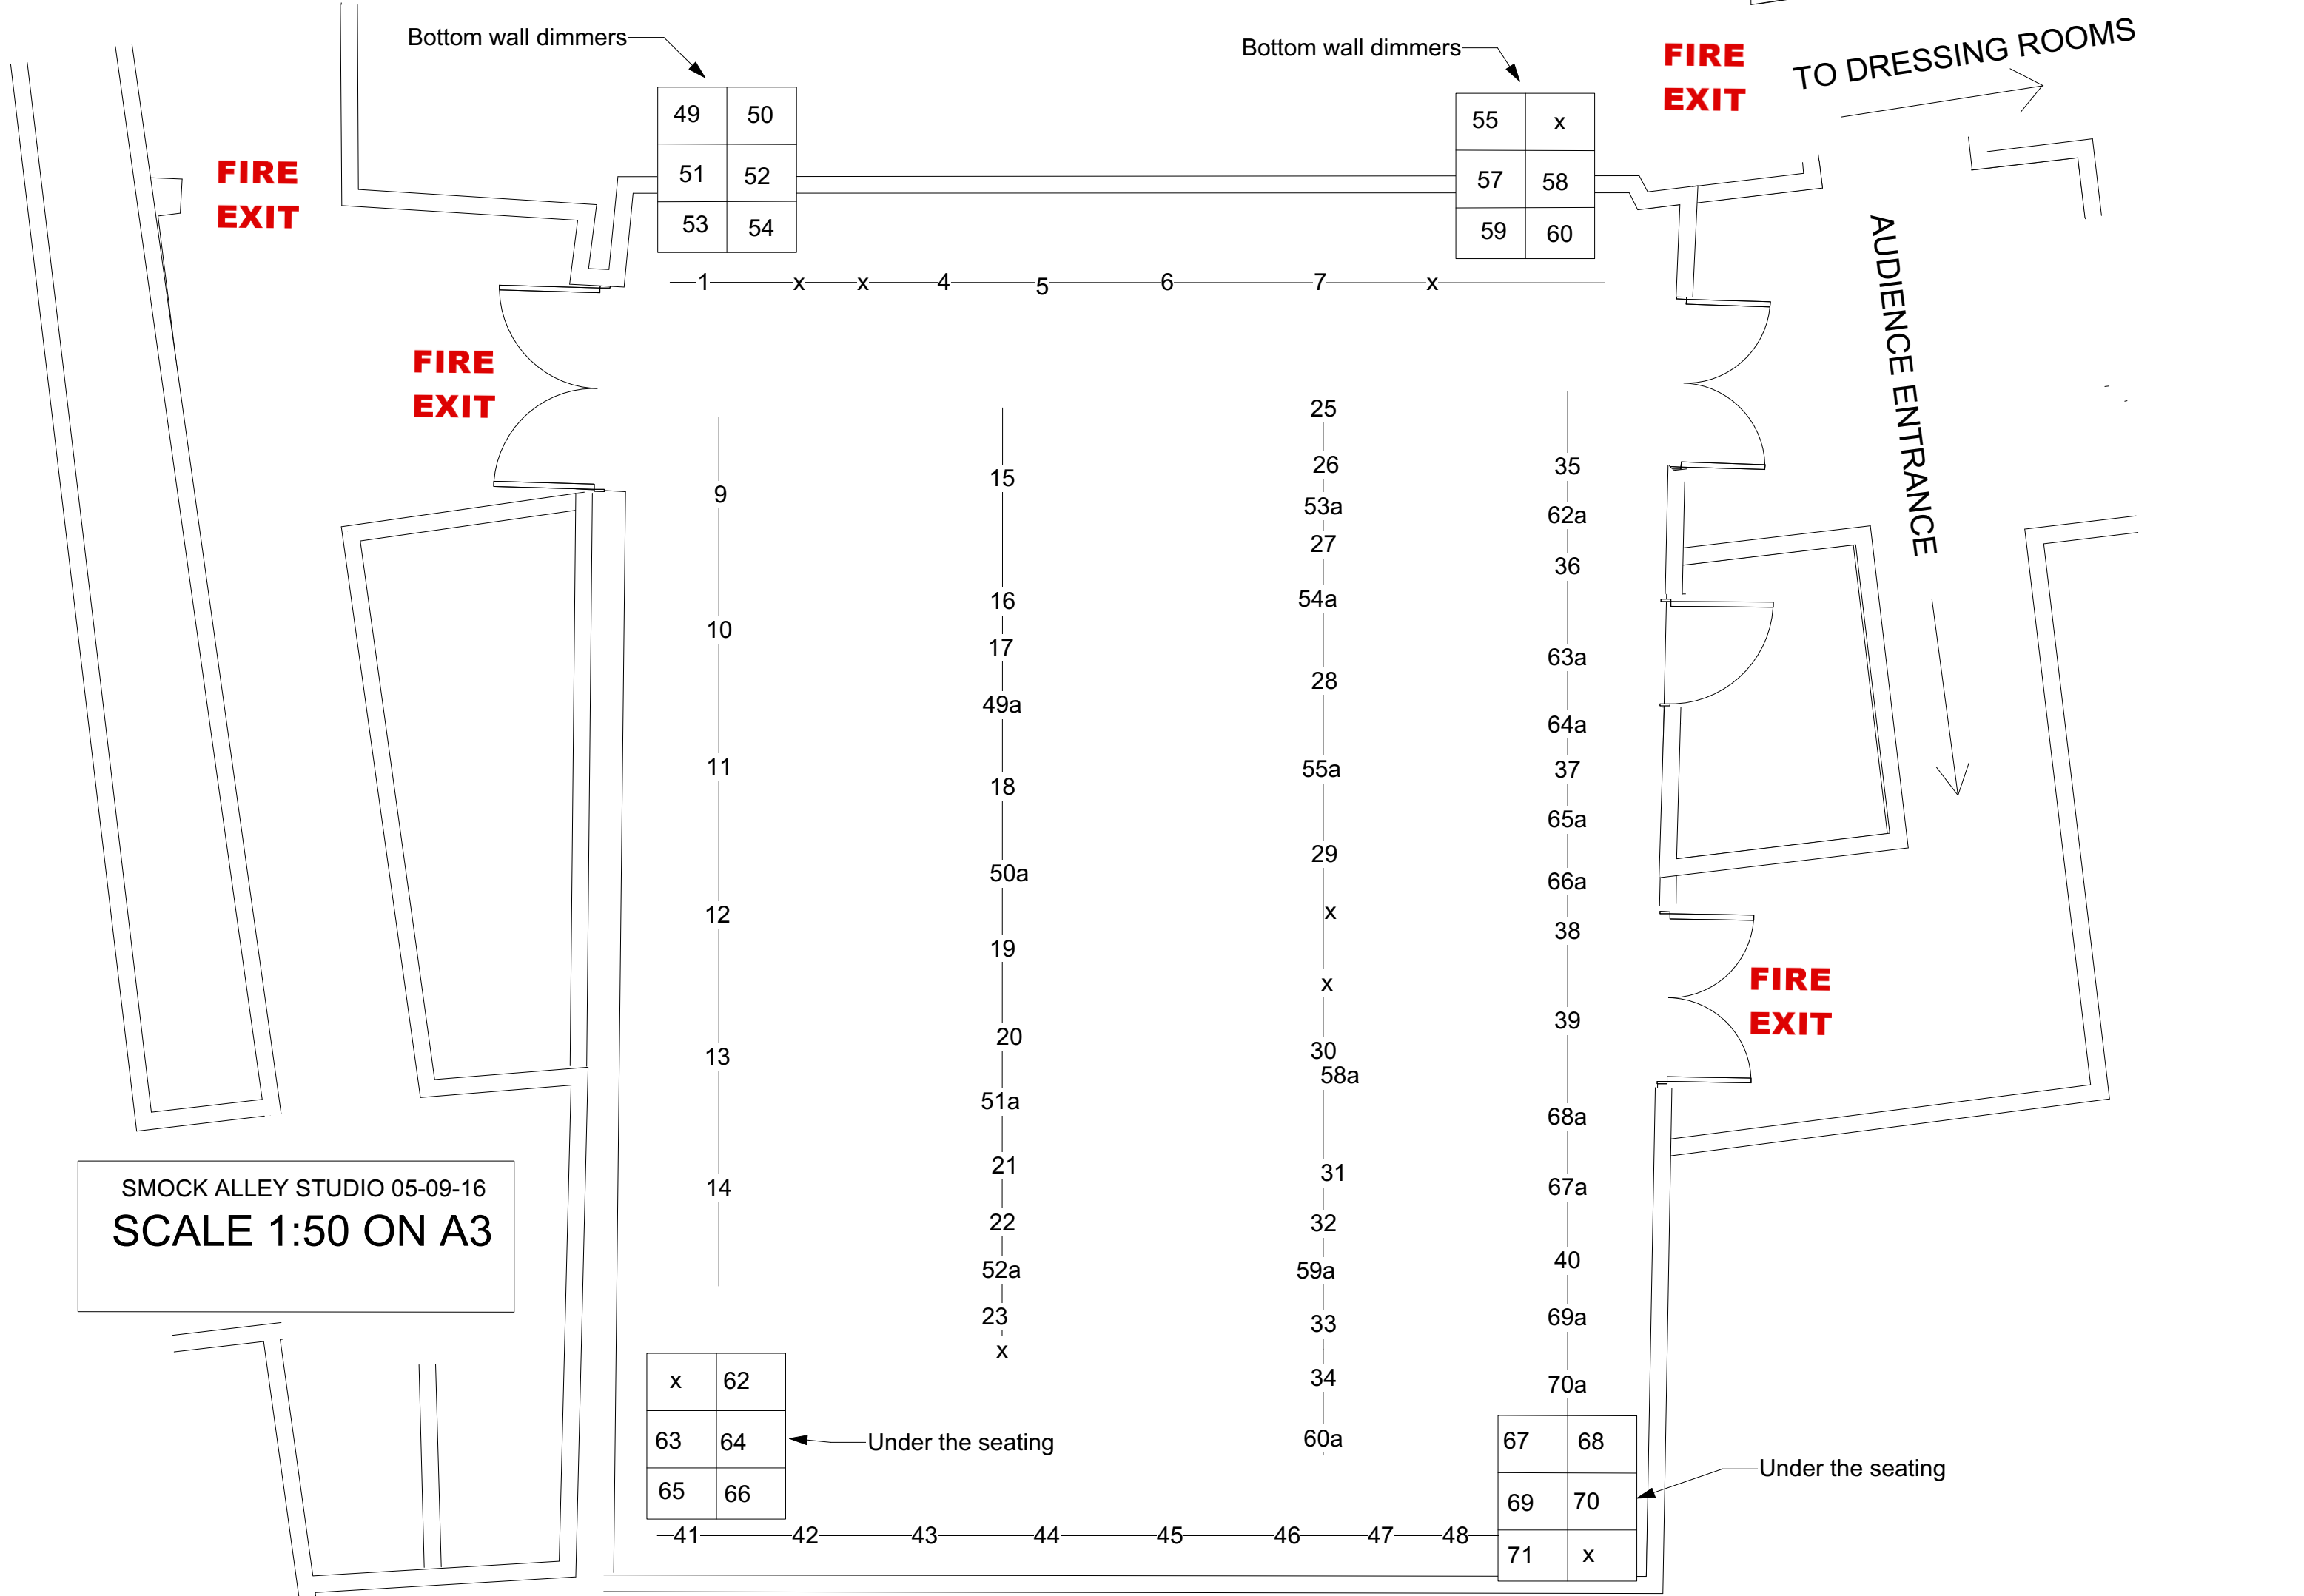

**FIRE
EXIT**

**FIRE
EXIT**

**FIRE
EXIT**

TO DRESSING ROOMS

AUDIENCE ENTRANCE

**FIRE
EXIT**

Bottom wall dimmers

Bottom wall dimmers

Under the seating

Under the seating

SMOCK ALLEY STUDIO 05-09-16
SCALE 1:50 ON A3

49	50
51	52
53	54

55	x
57	58
59	60

x	62
63	64
65	66

67	68
69	70
71	x

1 x x 4 5 6 7 x


41 42 43 44 45 46 47 48

9
10
11
12
13
14

15
16
17
49a
18
50a
19
20
51a
21
22
52a
23
x


25
26
53a
27
54a
28
55a
29
x
x
30
58a
31
32
59a
33
34
60a

35
62a
36
63a
64a
37
65a
66a
38
39
68a
67a
40
69a
70a

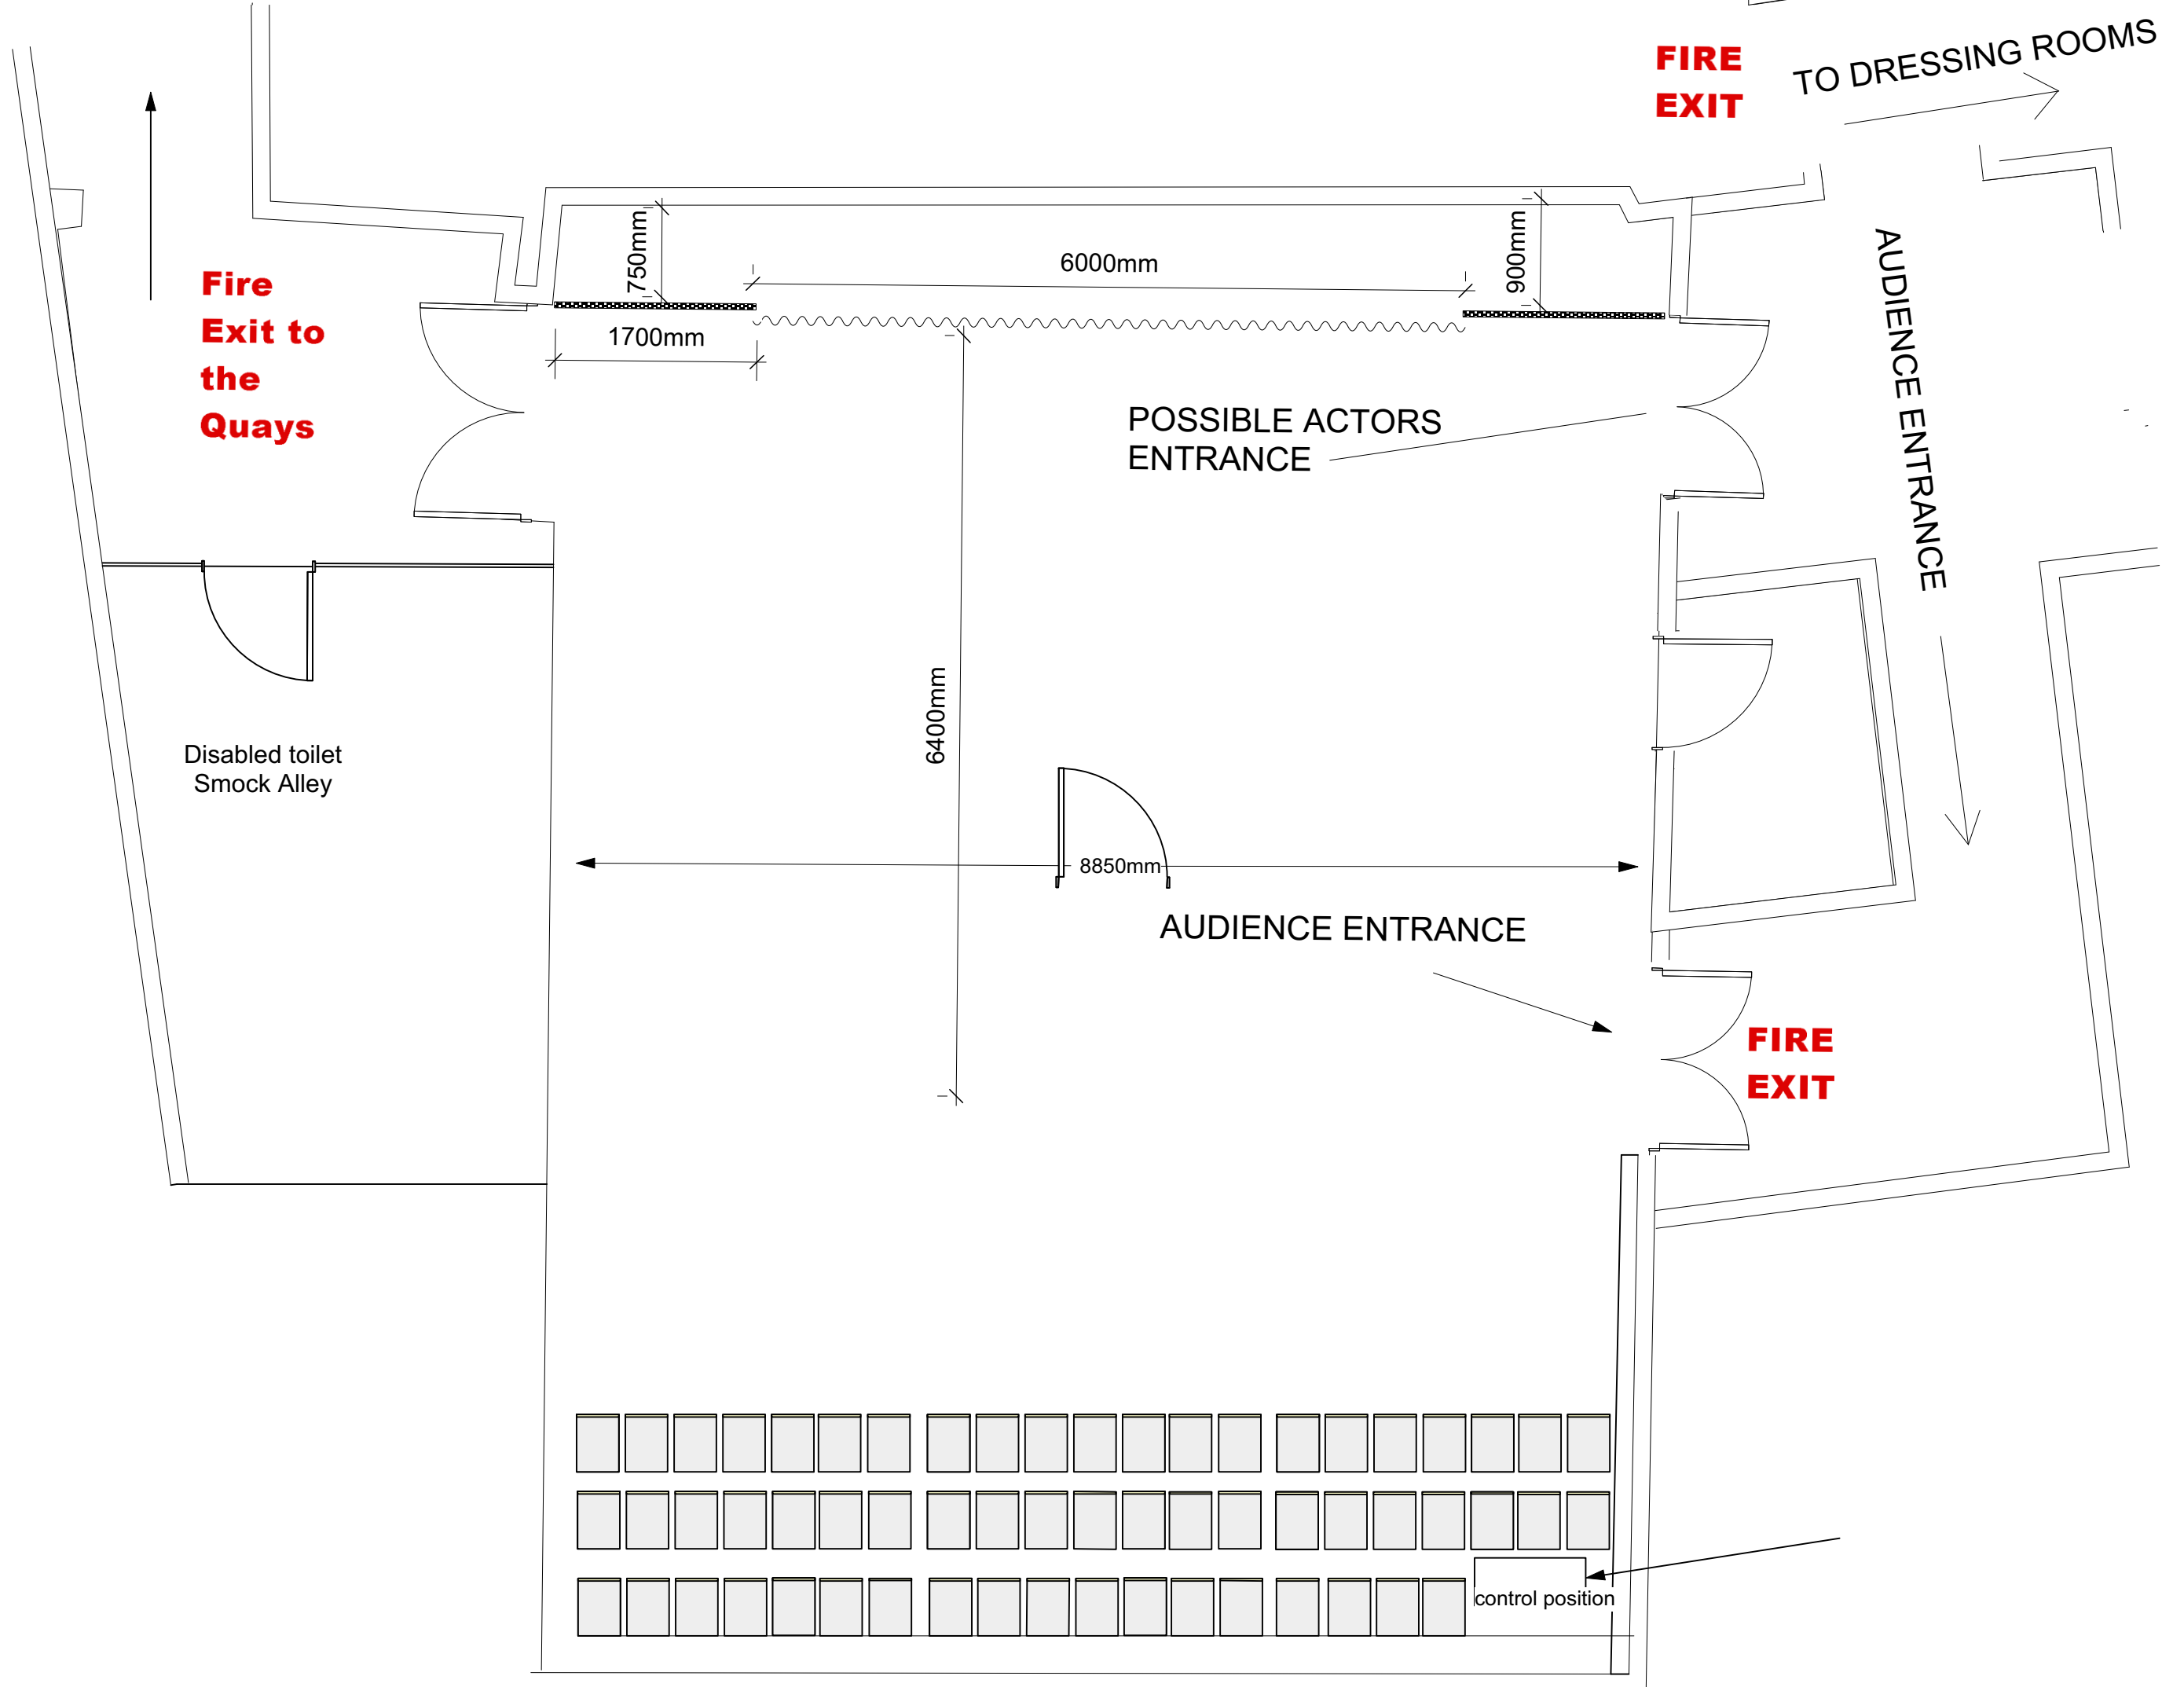


Side Elevation



Upstage Wall

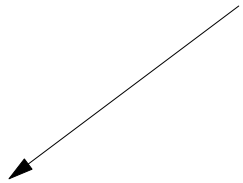

Stage Floor

 

Risers for the Seating Bank

 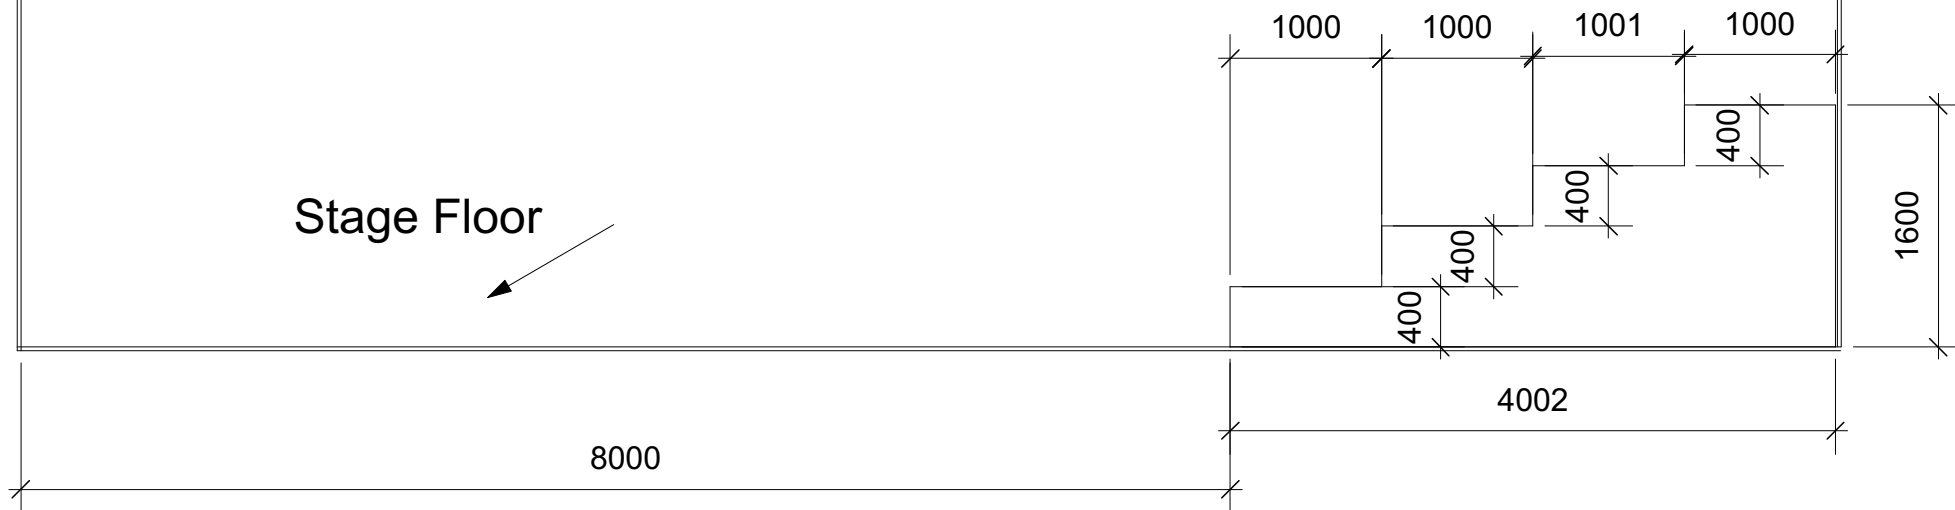

Black box side Elevation
Scale: 1:50

STOCK	Studio	USED	Remaining
S4 15/30	6		6
S4 25/50	3		3
Strand Preludes 28/40	6		6
Quartet 25's(Profiles) (Black)	0		0
Quartet 25's(Profile) (White)	0		0
Selecon Aurora 1k	2	2	0
Selecon Acclaim Fresnels	15	6	9
Source 4 Pars	6		6
Robert Juliat 310h 1200w Fresnels	12	12	0
Robert Juliat 310h 1200w Pc	2		2
Quartet F(Black)	0		0
Quartet PC			0
Quartet PC (White)	0		0
Source 4 fixed 19deg	0		0
Par 64 Cp62	0		0
Boom Arms			
Splitters			
Fanouts			
Cable			
DMX			